




Section 2
SO 499096

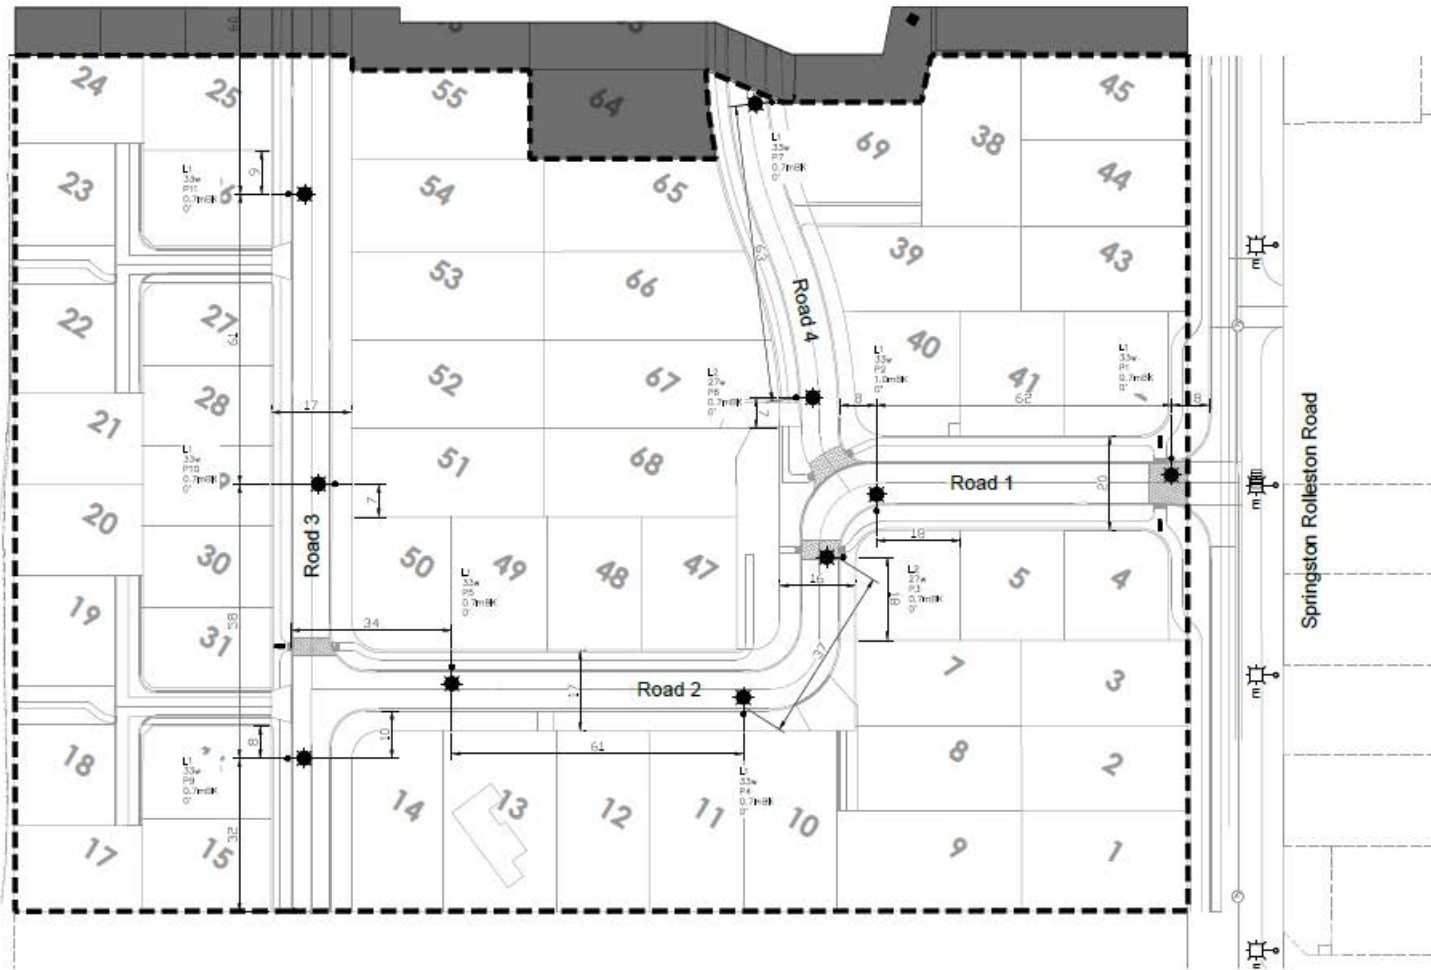

ISSUED FOR CONSTRUCTION
Sunday, October 18, 2020 10:48:45 AM

NOTES:

1. Refer to Sheet 1 for Lighting Schedule and Legend.



WINDSOR URBAN LTD.
ALL RIGHTS RESERVED.
UNAUTHORISED USE PROHIBITED

Rev	Description	Date	Des	Dr	Chk	App	Or App	Contractor	Designed	R. St-Denis / Conn	May 20
A	Issued to Client for Approval	22/05/20	RSD	RSD	-	-	-	-	Drawn	R. St-Denis / Conn	May 20
B	Issued to SDC for Approval	22/06/20	RSD	RSD	-	-	-	-	Checked	A. Kudinov / Conn	Oct 20
C	General Revision - Issued to SDC for Approval	13/10/20	RSD	RSD	-	-	-	-	Approved	B. Hayman for SDC	16-10-20

Scale
1:1000
Revision
C

STREETLIGHTING LAYOUT




Delapre Sub-Division
Stage 1
Rolleston



Size	Drawing Number	Sheet
A3	400090	2/3

1 : 1500
100
90
80
70
60
50
40
30
20
10
0

  1 : 1000
100
90
80
70
60
50
40
30
20
10
0

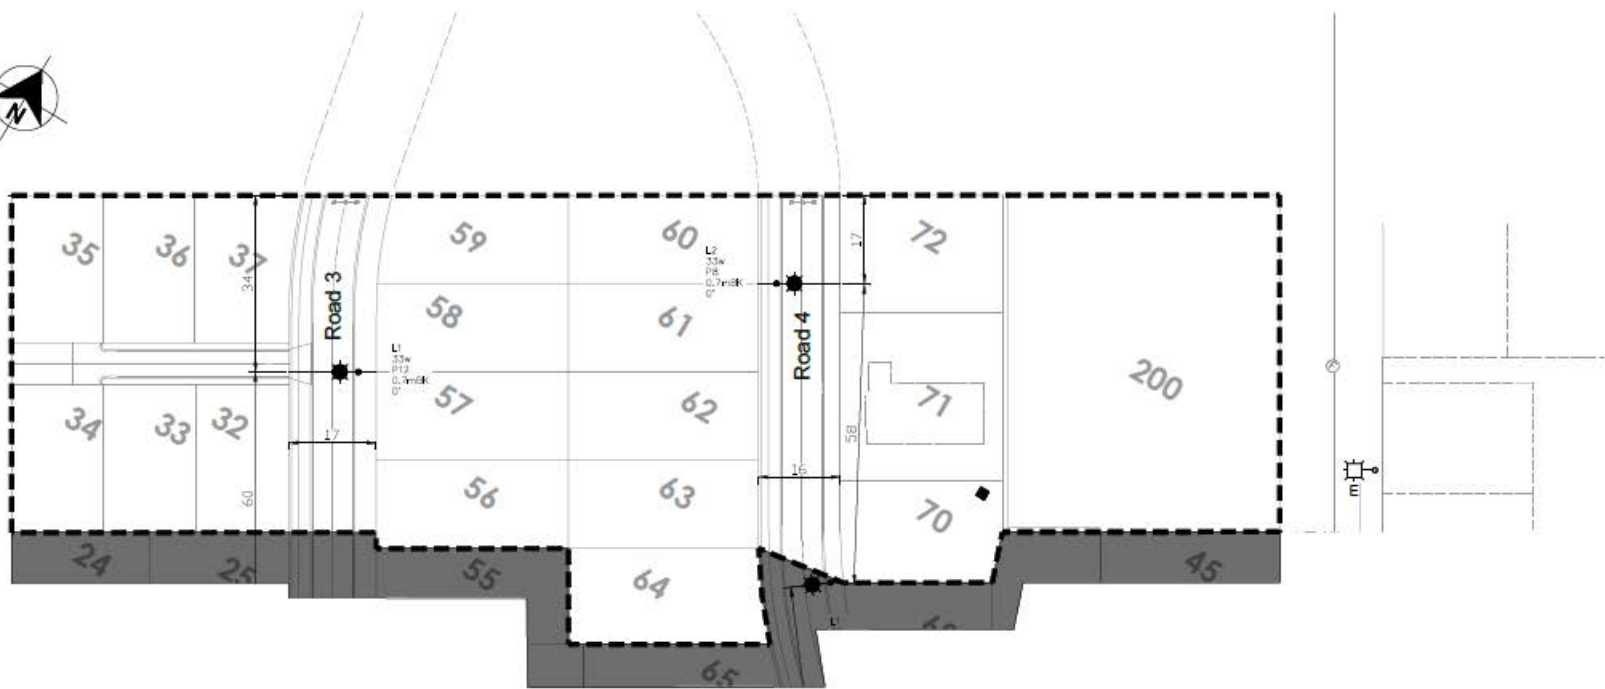

1 : 1000

ISSUED FOR CONSTRUCTION
Sunday, October 18, 2020 10:48:22 AM

- NOTES:**
1. Refer to Sheet 1 for Lighting Schedule and Legend.

WINDSOR URBAN LTD.
ALL RIGHTS RESERVED.
UNAUTHORISED USE PROHIBITED

Rev	Description	Date	Des	Dn	Chk	App	Or App	Contractor	Designed	R. St-Denis / Conn	May 20	Scale
A	Issued to Client for Approval	22/05/20	RSD	RSD	-	-	-	-	Drawn	R. St-Denis / Conn	May 20	1:1000
B	Issued to SDC for Approval	22/06/20	RSD	RSD	-	-	-	-	Checked	A. Kudinov / Conn	Oct 20	
C	General Revision - Issued to SDC for Approval	13/10/20	RSD	RSD	-	-	-	-	Approved	B. Hayman for SDC	16-10-20	
												Revision
												C

STREETLIGHTING LAYOUT

Delapre Sub-Division
Stage 2
Rolleston

Windsor Urban
LIGHTING FURNITURE

11 Wood Grove St, Rolleston, Canterbury, NZ
Tel: 03 384 0000 Fax: 03 384 0000 Email: info@windsorurban.co.nz

Size	Drawing Number	Sheet
A3	400090	3/3